

THIS DRAWING MUST BE READ IN CONJUNCTION
WITH ALL RELEVANT DRAWINGS & STRUCTURAL
CALCULATIONS

PROPOSED DWELLING

PROPOSED HB2 KERB

150mm STEP

PROPOSED ROAD CHANNEL WITH 1:150 CROSS FALL TOWARDS SITE ENTRANCE. OVERLAND FLOWS TO BE DIRECTED TO RIPARIAN DYKE TO SITE FRONTAGE.

5000

1:40 FALL

PROPOSED IMPERMEABLE TARMAC CONSTRUCTION




PROPOSED BN 25mm KERB

150mm STEP

PROPOSED DWELLING

TYPICAL SECTION THROUGH SHARED ACCESS ROAD

 SCALE 1:100

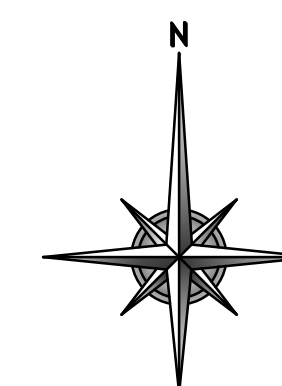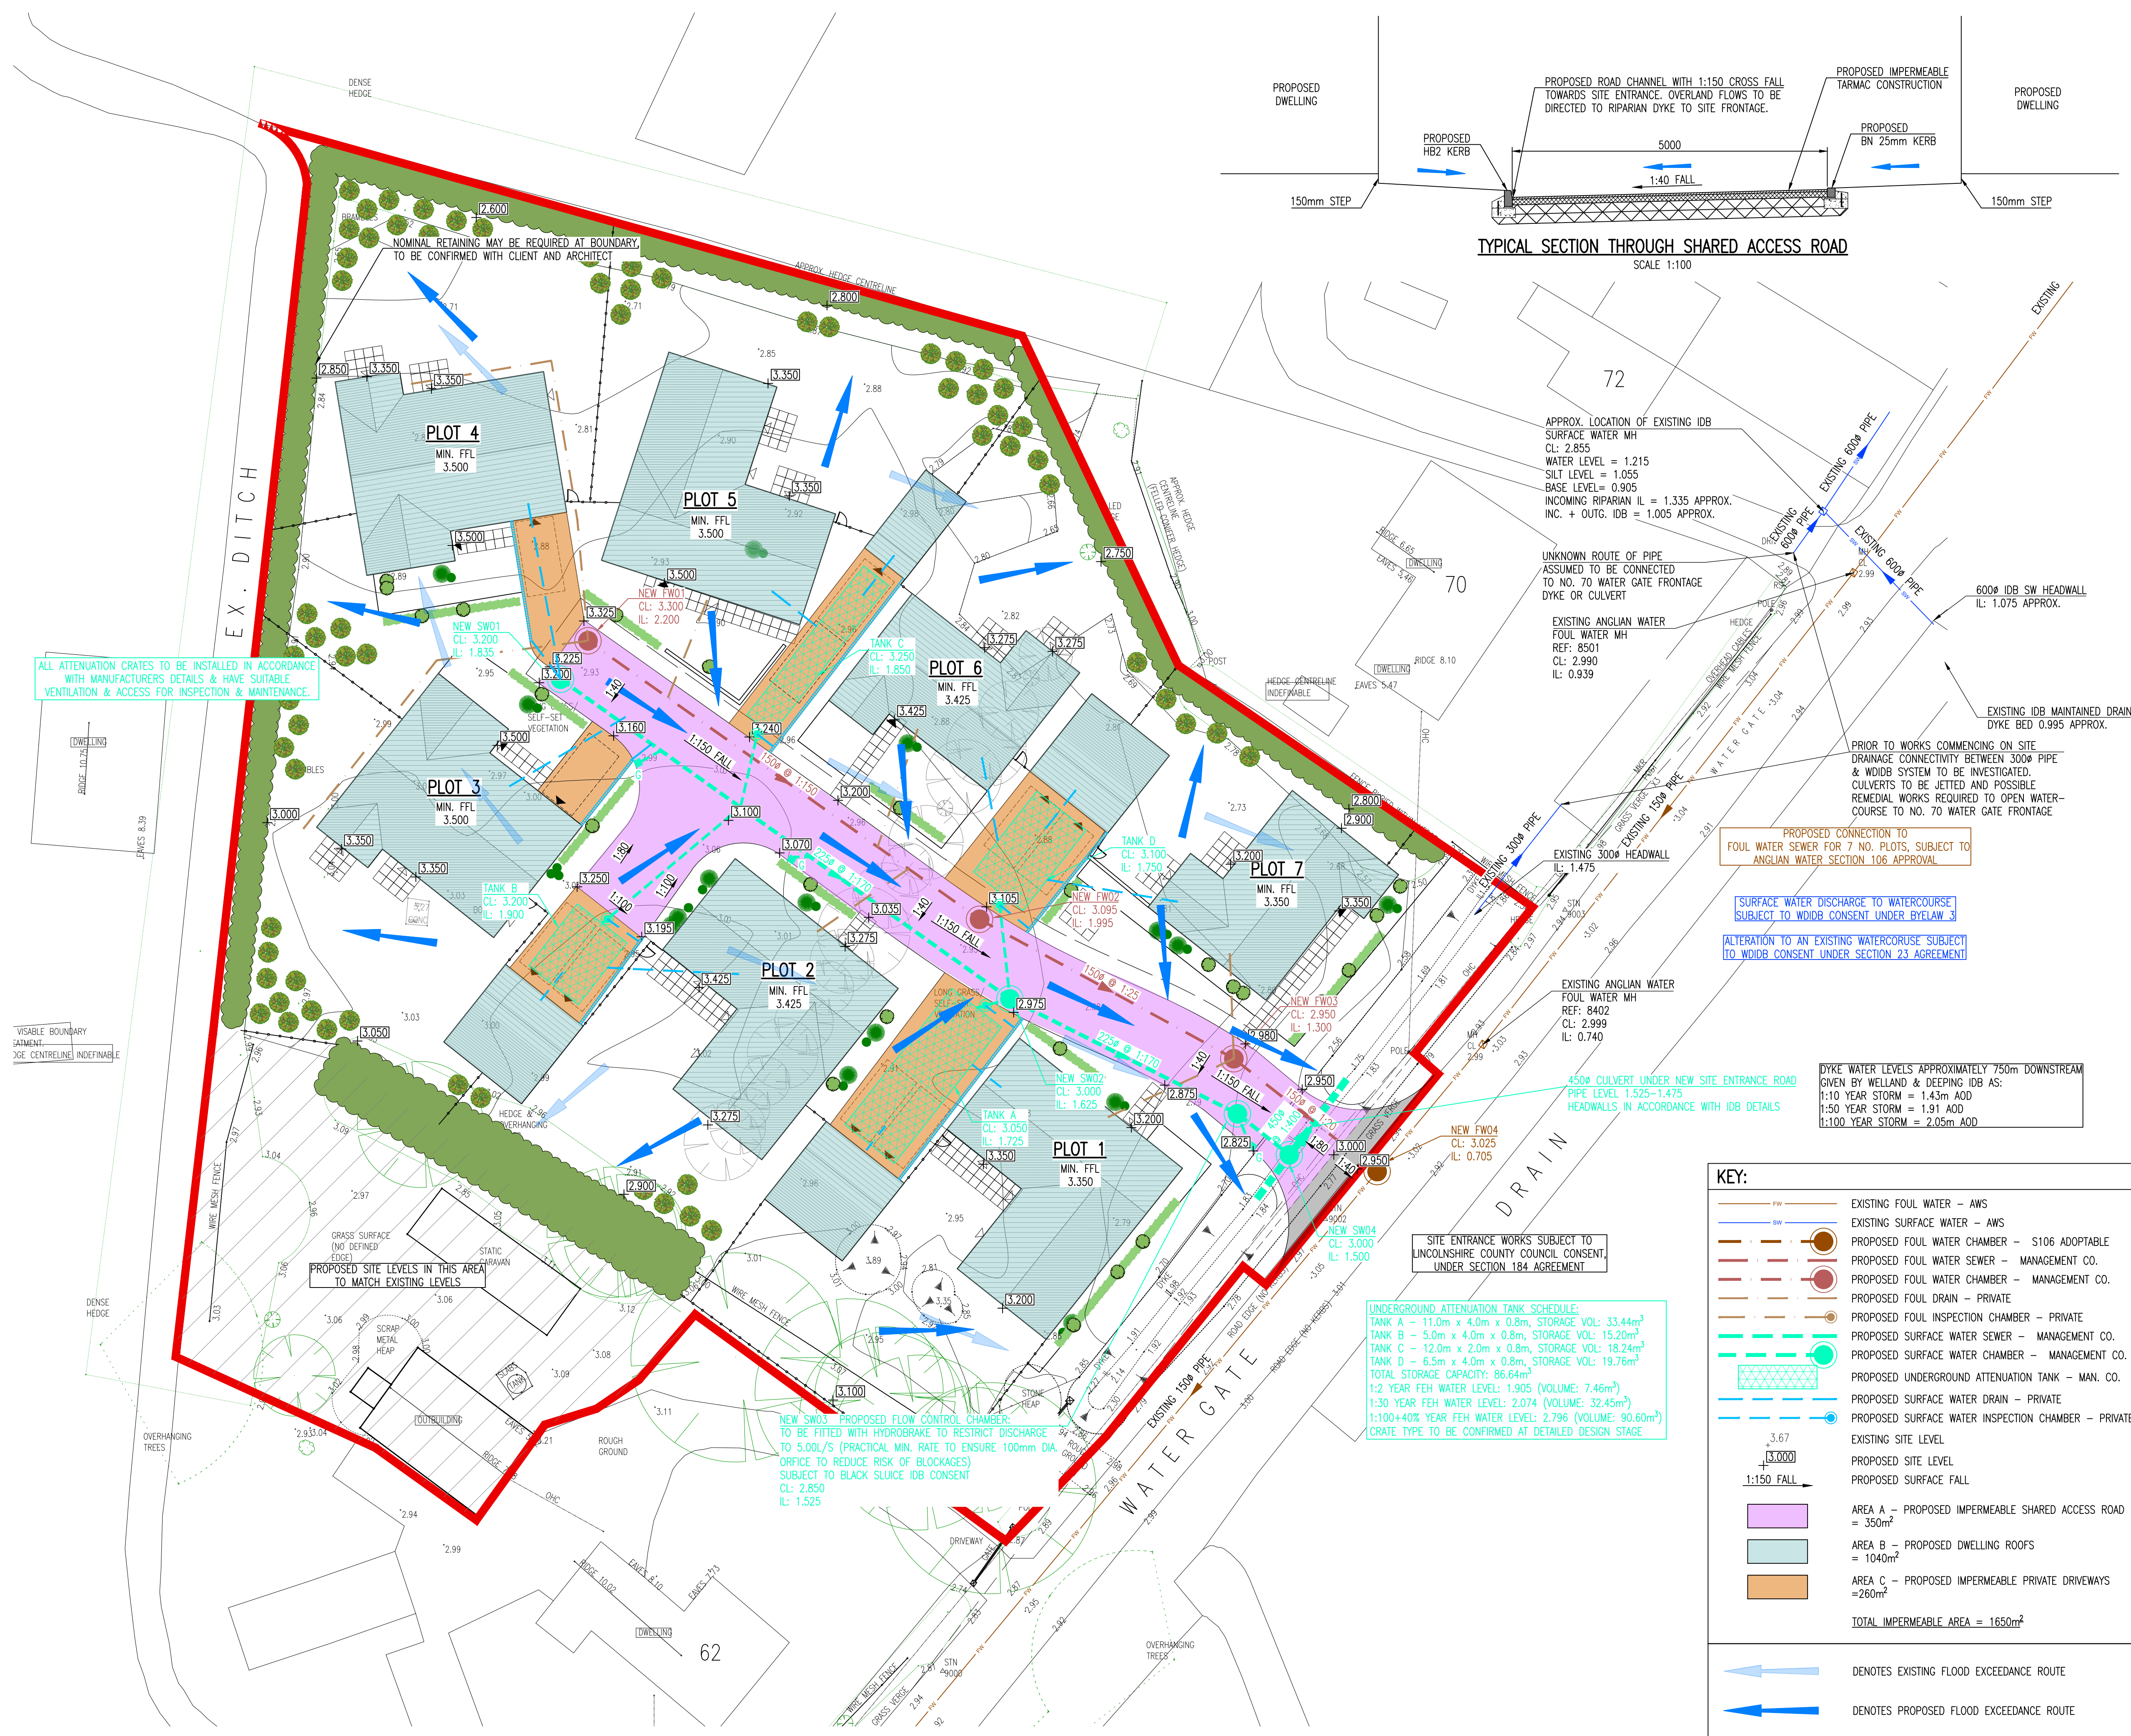

A	REVISION – MINOR ALTERATIONS TO GARAGE POSITIONS	MRS	APW	03.10.2017
–	PRELIMINARY – FOR INFORMATION	MRS	APW	24.09.2017
REV.	DESCRIPTION	DRN.	APP.	DATE

SHIELDSWILSON
e: info@shieldswilson.co.uk t: 01775 729252
STRUCTURAL AND CIVIL ENGINEERING

STATUS	FOR PLANNING
1	2
3	4
5	6
7	8
9	10
11	12
13	14
15	16
17	18
19	20
21	22
23	24
25	26
27	28
29	30
31	32
33	34
35	36
37	38
39	40
41	42
43	44
45	46
47	48
49	50
51	52
53	54
55	56
57	58
59	60
61	62
63	64
65	66
67	68
69	70
71	72
73	74
75	76
77	78
79	80
81	82
83	84
85	86
87	88
89	90
91	92
93	94
95	96
97	98
99	100

CLIENT	CLARKE GROUP CONSTRUCTION LTD.
--------	--------------------------------

PROJECT	PROPOSED 7 PLOT RESIDENTIAL DEVELOPMENT ADJACENT 62 WATER GATE, QUADRING,
---------	--

TITLE	PROPOSED DRAINAGE LAYOUT
-------	--------------------------

DATE	SEP. '24	SCALE $\text{1/4"=1'-0"} \times 1/2$ 1:200	DRAWING NO. SW24-223-001	REV. A
DRAWN	MRB			