


PLANTING DETAIL 1 - COURTYARD GARDEN
Scale 1:50

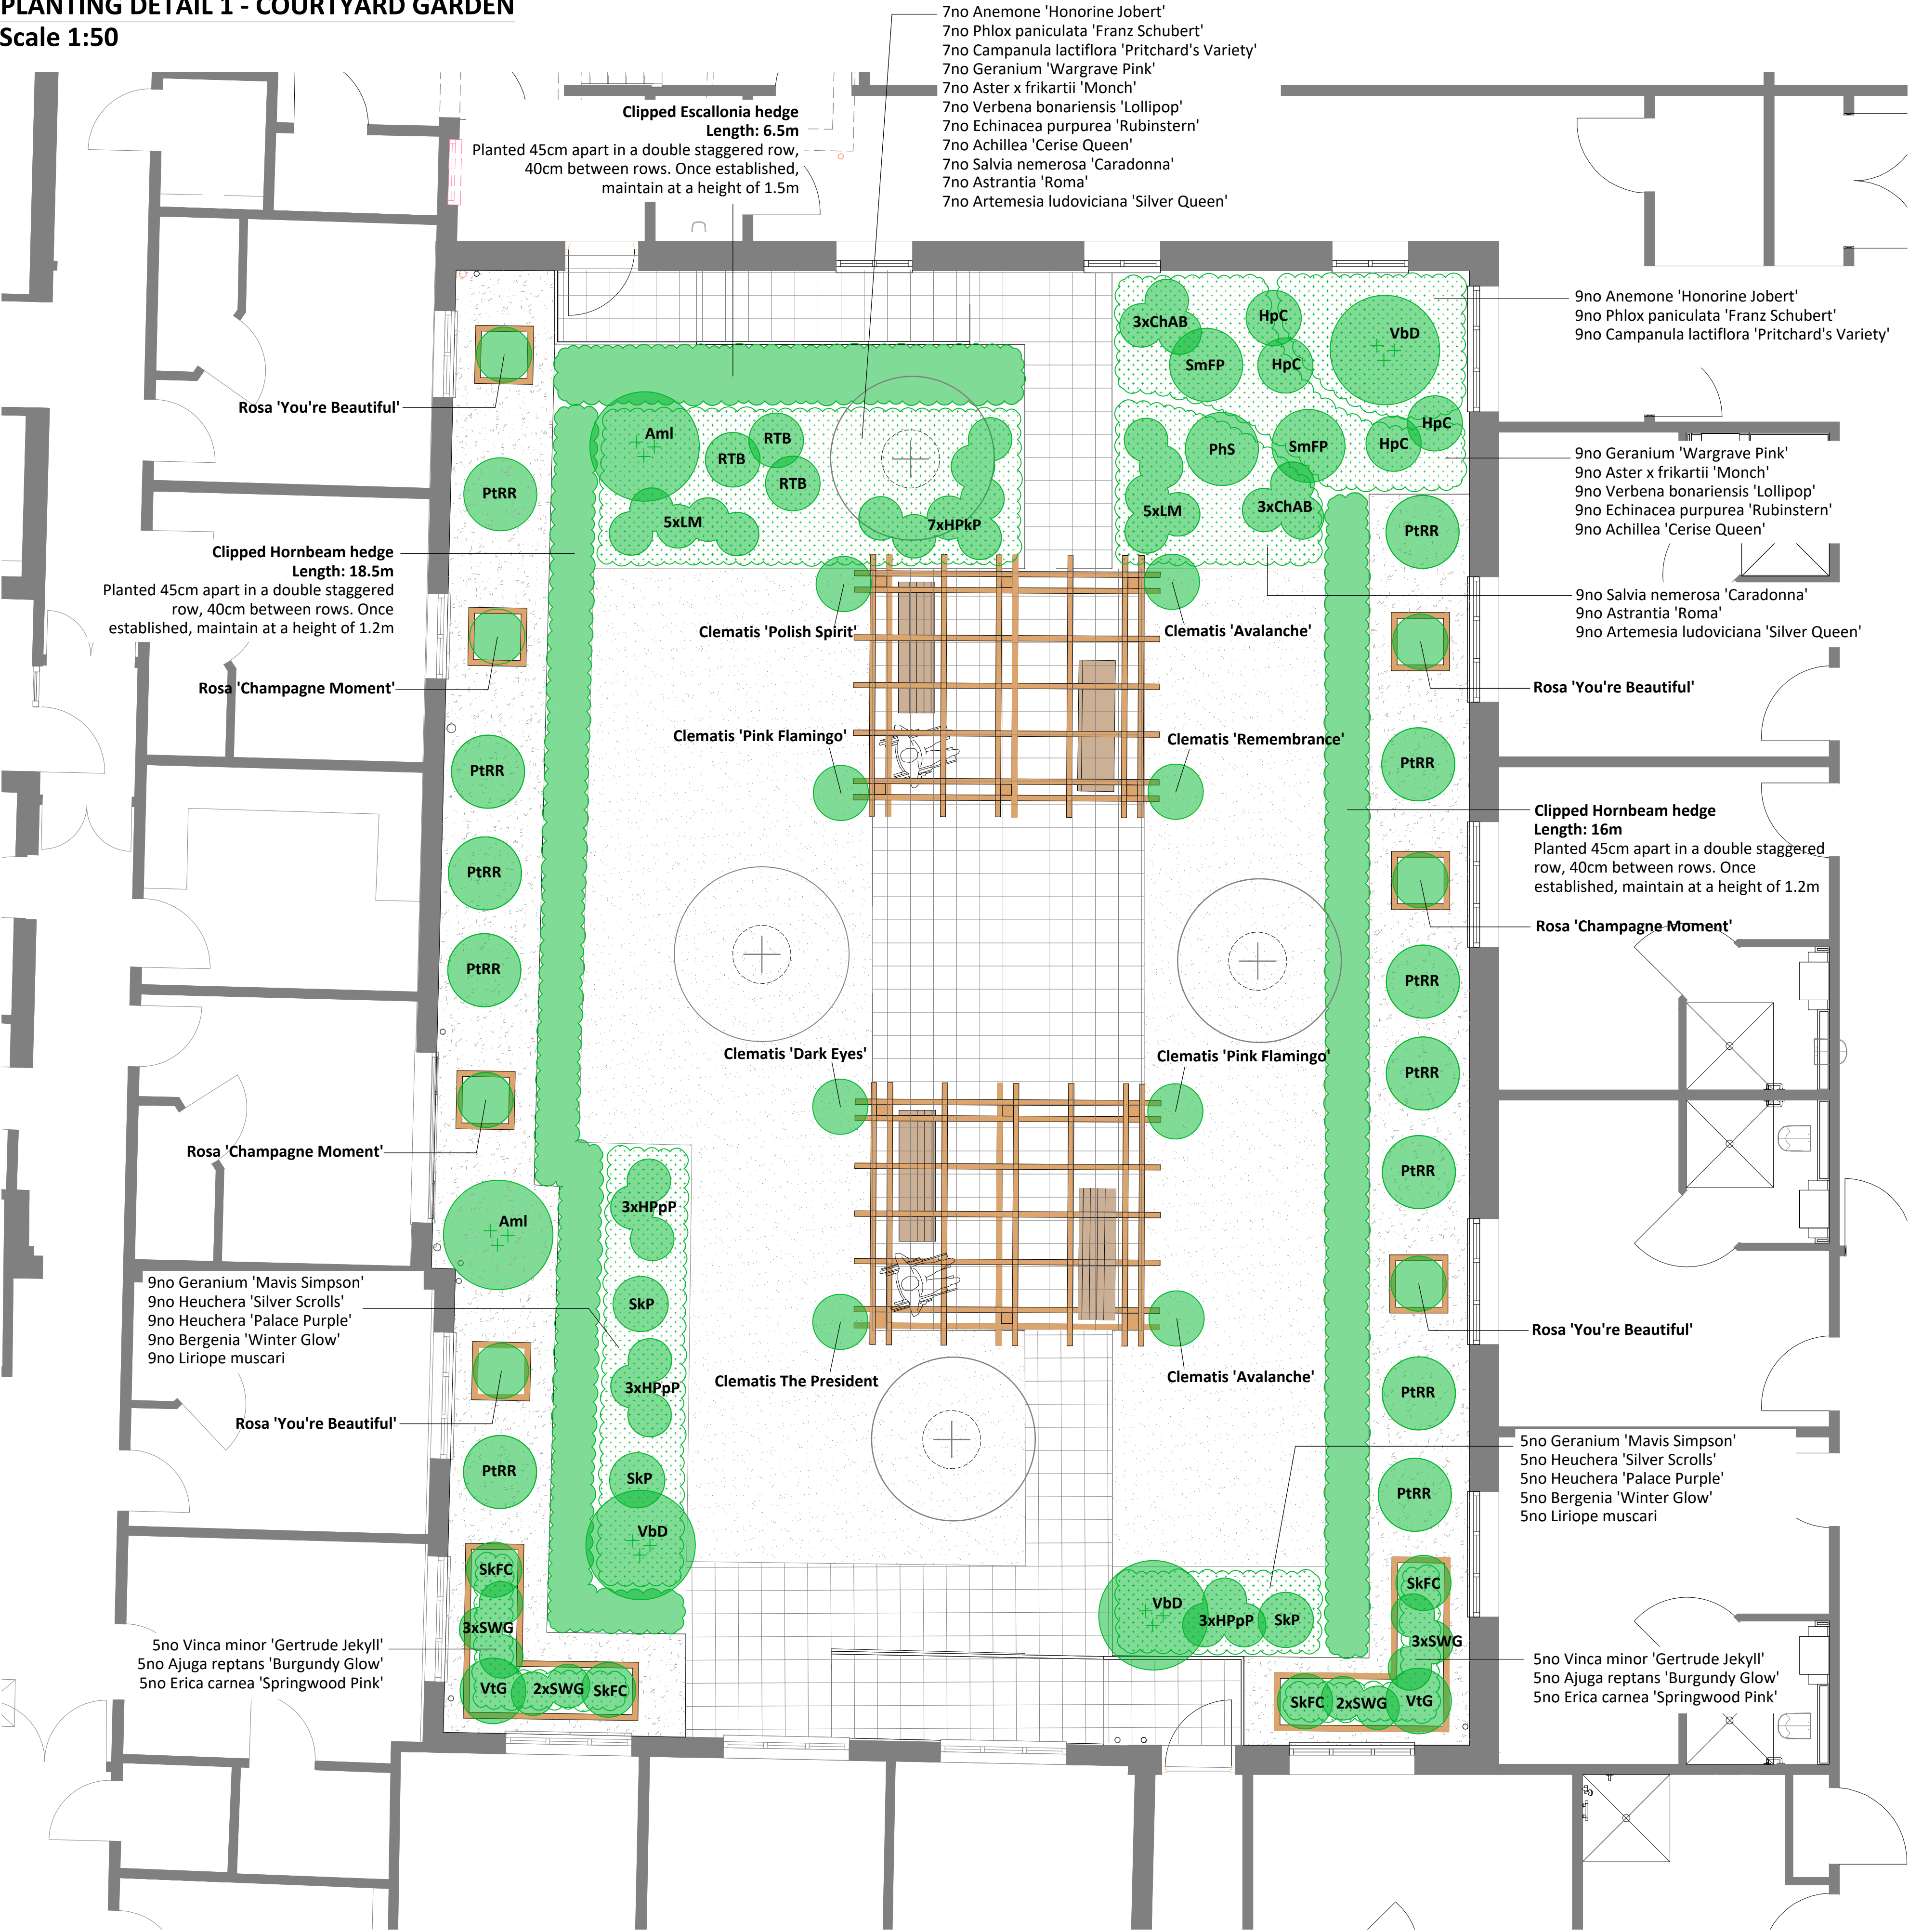

PLANT SCHEDULE - PLANTING DETAIL 1


Species	Height	Size	Spacing	Qty
Clematis 'Avalanche'	60cm	3 litre container	specimen	2
Clematis 'Dark Eyes'	60cm	3 litre container	specimen	1
Clematis 'Pink Flamingo'	60cm	3 litre container	specimen	2
Clematis 'Polish Spirit'	60cm	3 litre container	specimen	1
Clematis 'Remembrance'	60cm	3 litre container	specimen	1
Clematis 'The President'	60cm	3 litre container	specimen	1

ORNAMENTAL SHRUBS, PERENNIALS & HEDGES

Species	Height	Size	Spacing	Qty
Flowering Shrubs				
Amelanchier lamarckii (Aml)	80-100cm	10 litre container	specimen	2
Choisya x dewitteana 'Apple Blossom' (ChAB)	40-60cm	5 litre container	60cm apart	6
Erica carnea 'Springwood White'	2 litre container	30cm apart	specimen	10
Hebe 'Pink Pixie' (HPKP)	30-40cm	5 litre container	40cm apart	7
Hebe 'Purple Pixie' (HPpP)	30-40cm	5 litre container	40cm apart	9
Hydrangea paniculata 'Confetti' (HpC)	40-60cm	10 litre container	specimen	4
Lavandula angustifolia 'Munstead' (LM)	30-40cm	5 litre container	40cm apart	10
Philadelphus 'Snowbelle' (PHS)	40-60cm	10 litre container	specimen	1
Rosa 'Champagne Moment'	-	5 litre container	specimen	3
Rosa 'You're Beautiful'	-	5 litre container	specimen	4
Rosmarinus officinalis 'Tuscan Blue' (RTB)	40-60cm	10 litre container	75cm apart	3
Sarcococca hookeriana 'Winter Gem' (SWG)	30-40cm	3 litre container	50cm apart	10
Skimmia japonica 'Fragrant Cloud' (SKFC)	40-60cm	5 litre container	specimen	4
Skimmia japonica 'Perosa' (SKP)	30-40cm	5 litre container	40cm apart	3
Syringa meyeri 'Flowerfesta Pink' (SmFP)	60-80cm	10 litre container	specimen	2
Viburnum x bodnantense 'Dawn' (VbD)	80-100cm	10 litre container	specimen	3
Viburnum tinus 'Gwenllian' (VtG)	40-60cm	5 litre container	specimen	2
Vinca minor 'Gertrude Jekyll'	20-30cm	2 litre container	30cm apart	10
Ornamental Hedging				
Carpinus betulus	60-80cm	1+1 BR transplant	45cm apart	173
Escallonia 'Iveyi'	40-60cm	3 litre container	45cm apart	33
Topiary Shrubs				
Photinia x fraseri 'Red Robin'	-	150-175cm Cone	specimen	12
Perennials				
Achillea millefolium 'Cerise Queen'	-	2 litre container	40cm	16
Ajuga reptans 'Burgundy Glow'	-	2 litre container	40cm	10
Anemone x hybrida 'Honorine Jobert'	-	2 litre container	40cm	16
Artemisia ludoviciana 'Silver Queen'	-	2 litre container	40cm	16
Aster x frikartii 'Monch'	-	2 litre container	40cm	16
Astrantia major 'Roma'	-	2 litre container	40cm	16
Bergenia cordifolia 'Winter Glow'	-	2 litre container	40cm	14
Campanula lactiflora 'Pritchard's Variety'	-	2 litre container	40cm	16
Echinacea purpurea 'Rubinstern'	-	2 litre container	40cm	16
Geranium 'Mavis Simpson'	-	2 litre container	40cm	14
Geranium 'Wargrave Pink'	-	2 litre container	40cm	16
Heuchera 'Palace Purple'	-	2 litre container	40cm	14
Heuchera 'Silver Scrolls'	-	2 litre container	40cm	14
Liriope muscari	-	2 litre container	40cm	16
Phlox paniculata 'Franz Schubert'	-	2 litre container	40cm	16
Salvia nemerosa 'Caradonna'	-	2 litre container	40cm	16
Verbena bonariensis 'Lollipop'	-	2 litre container	40cm	16

Perennials shall be planted in single-species groups of 5, 7 or 9, 40cm apart

PLANTING DETAIL 2 - MEADOW GARDEN
Scale 1:50

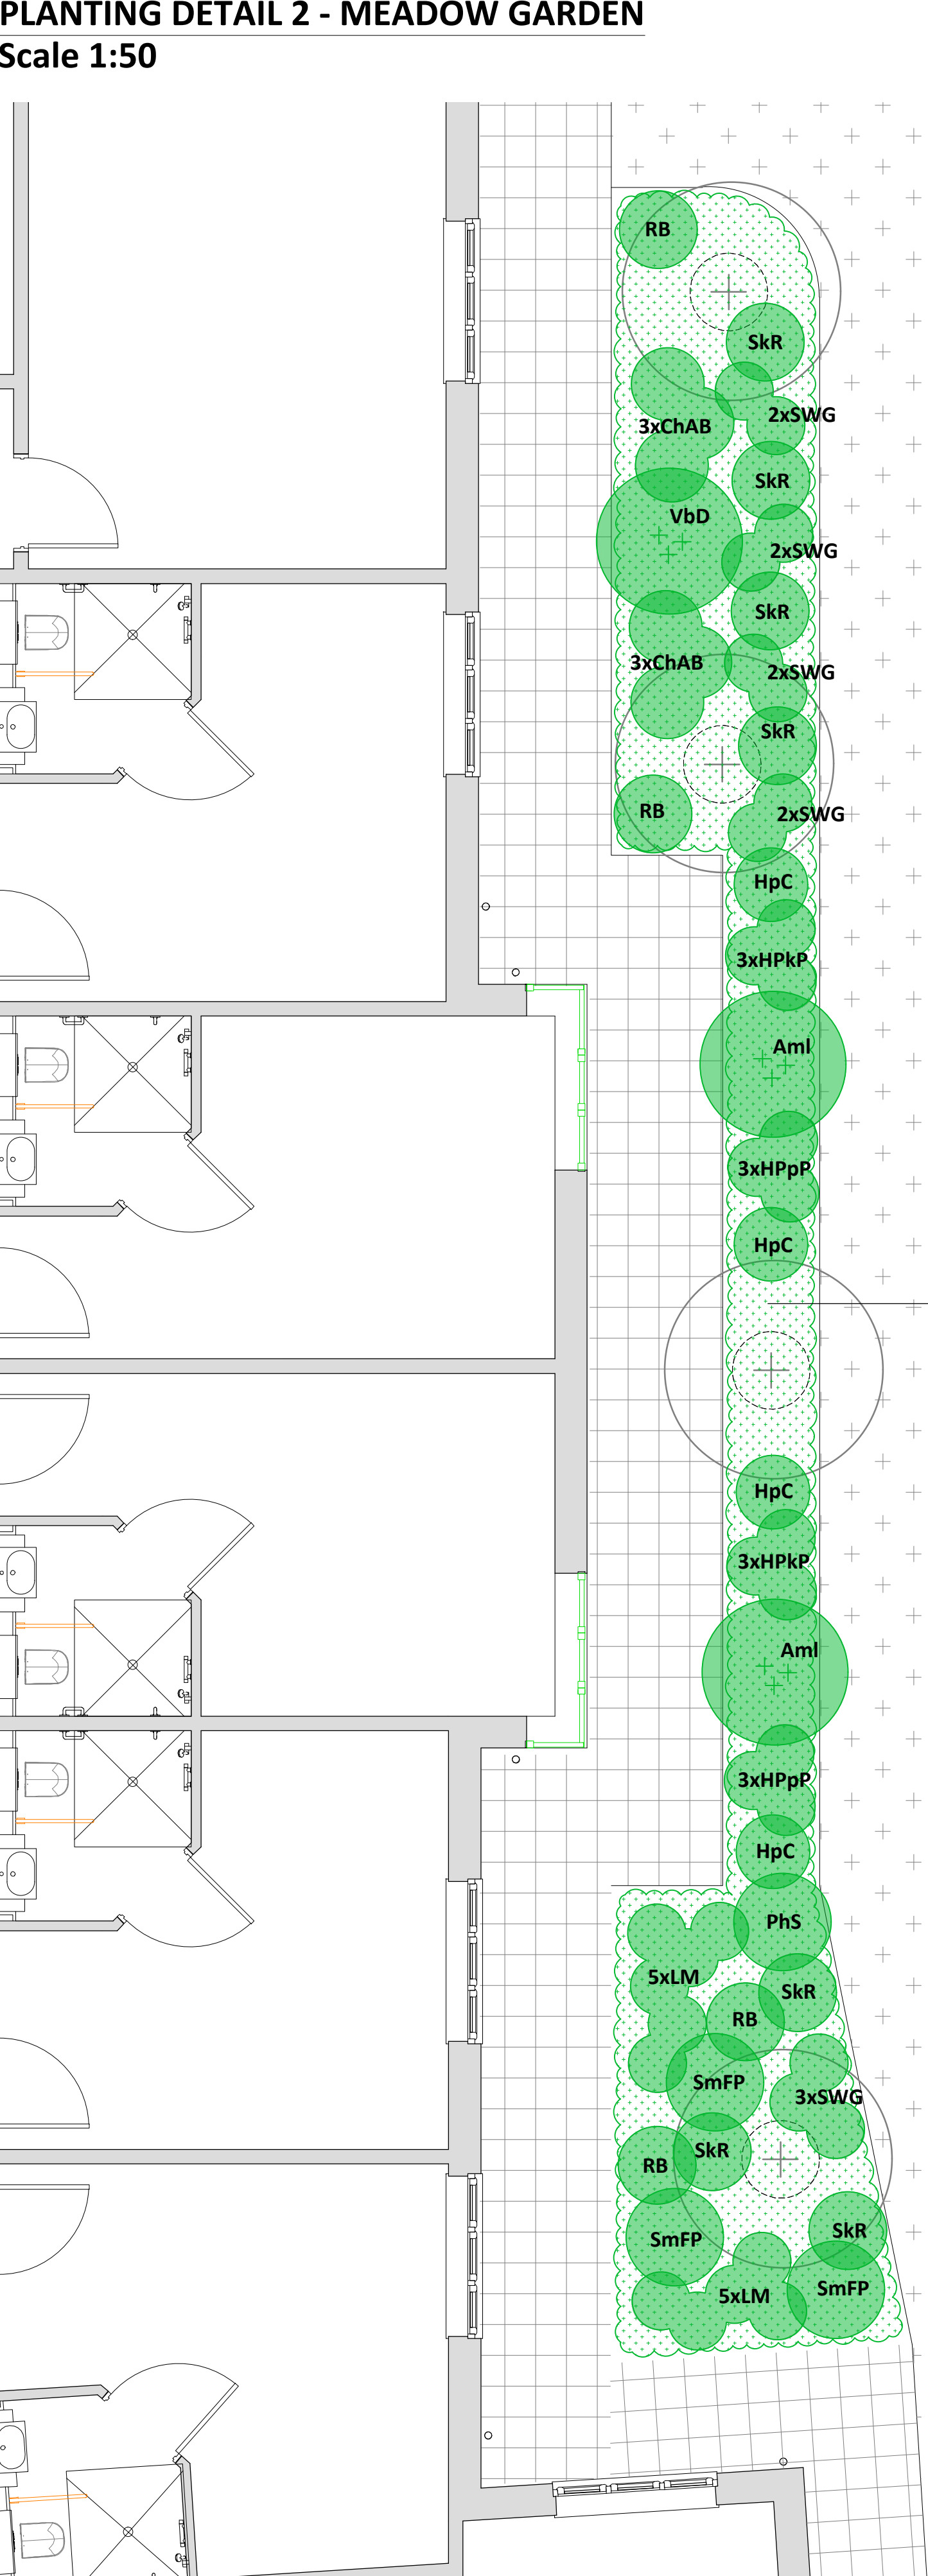


PLANT SCHEDULE - PLANTING DETAIL 2

Species	Height	Size	Spacing	Qty
Flowering Shrubs				
Amelanchier lamarckii (Aml)	80-100cm	10 litre container	specimen	2
Choisya x dewitteana 'Apple Blossom' (ChAB)	40-60cm	5 litre container	60cm apart	6
Hebe 'Pink Pixie' (HPKP)	30-40cm	5 litre container	40cm apart	6
Hebe 'Purple Pixie' (HPpP)	30-40cm	5 litre container	40cm apart	6
Hydrangea paniculata 'Confetti' (HpC)	40-60cm	10 litre container	specimen	4
Lavandula angustifolia 'Munstead' (LM)	30-40cm	5 litre container	40cm apart	10
Philadelphus 'Snowbelle' (PHS)	40-60cm	10 litre container	specimen	1
Rosa 'Bonica' (RB)	40-60cm	10 litre container	75cm apart	4
Sarcococca hookeriana 'Winter Gem' (SWG)	30-40cm	3 litre container	50cm apart	11
Skimmia japonica 'Rubella' (SKR)	40-60cm	5 litre container	specimen	7
Syringa meyeri 'Flowerfesta Pink' (SmFP)	60-80cm	10 litre container	specimen	3
Viburnum x bodnantense 'Dawn' (VbD)	80-100cm	10 litre container	specimen	1
Perennials				
Achillea millefolium 'Cerise Queen'	-	2 litre container	40cm	14
Anemone x hybrida 'Honorine Jobert'	-	2 litre container	40cm	14
Artemisia ludoviciana 'Silver Queen'	-	2 litre container	40cm	14
Aster x frikartii 'Monch'	-	2 litre container	40cm	14
Astrantia major 'Roma'	-	2 litre container	40cm	14
Bergenia corifolia 'Winter Glow'	-	2 litre container	40cm	14
Campanula lactiflora 'Pritchard's Variety'	-	2 litre container	40cm	14
Echinacea purpurea 'Rubinstern'	-	2 litre container	40cm	14
Geranium 'Mavis Simpson'	-	2 litre container	40cm	14
Geranium 'Wargrave Pink'	-	2 litre container	40cm	14
Heuchera 'Palace Purple'	-	2 litre container	40cm	14
Heuchera 'Silver Scrolls'	-	2 litre container	40cm	14
Liriope muscari	-	2 litre container	40cm	14
Phlox paniculata 'Franz Schubert'	-	2 litre container	40cm	14
Salvia nemerosa 'Caradonna'	-	2 litre container	40cm	14
Verbena bonariensis 'Lollipop'	-	2 litre container	40cm	14

Perennials shall be planted in single-species groups, 2 groups of 7 per species, 40cm apart, with groups evenly distributed throughout the planting bed

PLANTING DETAIL 3 - CAR PARK & SITE FRONTAGE
Scale 1:200

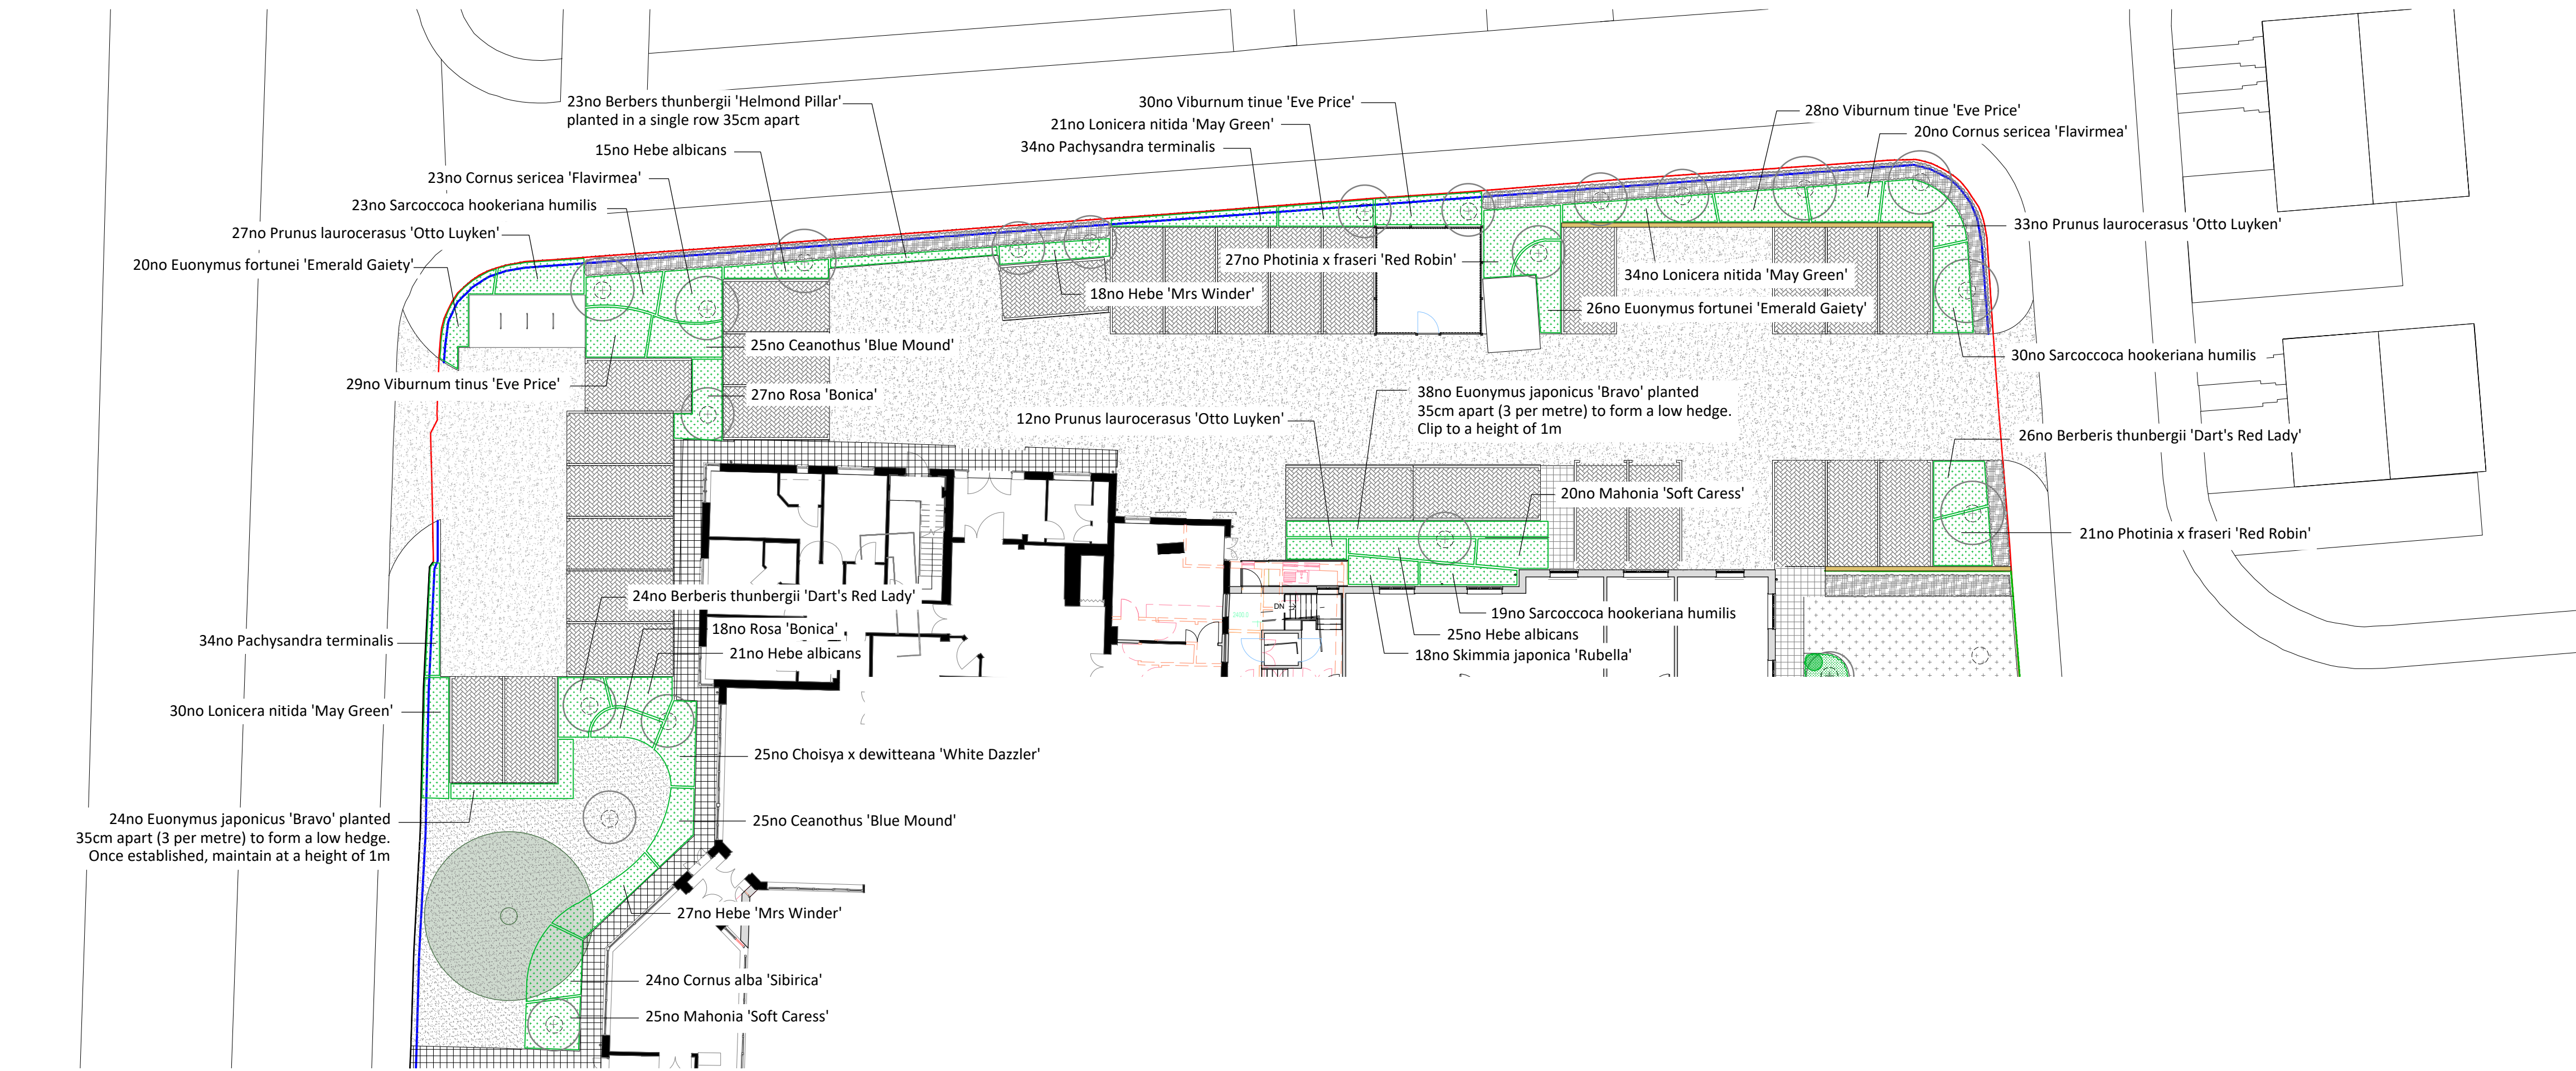

PLANT SCHEDULE - PLANTING DETAIL 3

Species	Height	Size	Spacing	Qty
Flowering Shrubs				
Berberis thunbergii 'Dart's Red Lady'	30-40cm	3 litre container	4/m2	50
Berberis thunbergii 'Helmold Pillar'	30-40cm	3 litre container	35cm apart	23
Ceanothus 'Blue Mound'	30-40cm	3 litre container	4/m2	50
Choisya x dewitteana 'White Dazzler'	30-40cm	3 litre container	4/m2	25
Cornus alba 'Sibirica'	60-80cm	3 litre container	3/m2	24
Cornus sericea 'Flaviramea'	60-80cm	3 litre container	3/m2	43
Euonymus fortunei 'Emerald Gaiety'	30-40cm	5 litre container	4/m2	46
Euonymus japonicus 'Bravo'	30-40cm	3 litre container	45cm apart	62
Hebe albicans	30-40cm	5 litre container	4/m2	61
Hebe 'Mrs Winder'	30-40cm	5 litre container	4/m2	45
Lonicera nitida 'Maygreen'	30-40cm	3 litre container	4/m2	45
Mahonia 'Soft Caress'	30-40cm	3 litre container	4/m2	45
Pachysandra terminalis	15-20cm	2 litre container	5/m2	68
Photinia x fraseri 'Red Robin'	30-40cm	3 litre container	3/m2	48
Prunus laurocerasus 'Otto Luyken'	30-40cm	3 litre container	3/m2	72
Rosa 'Bonica'	30-40cm	3 litre container	3/m2	45
Sarcococca hookeriana humilis	30-40cm	5 litre container	4/m2	72
Skimmia japonica 'Rubella'	30-40cm	3 litre container	4/m2	18
Viburnum tinus 'Eve Price'	30-40cm	3 litre container	4/m2	87

DRAWING NOTES
This drawing is based on Linestyle Studio Proposed Site Plan 0443 002 3C.
KOVA Landscape Ltd. accept no responsibility or liability for any use that is made of this drawing other than by the client for the purposes for which it was originally commissioned or prepared.

Location of specimen trees and shrubs indicative only, subject to final location of underground services and drainage layout.

PLANNING

Pl: First Issue	LK	22.05.25
Revisions:	Dwn:	Date:
Client:	Country Court Care Group	
Project:	Proposed Extension to Ashwood Care Home, Spalding Common, Spalding	
Drawing:	Soft Landscaping & Tree Planting - Sheet 2 of 2	
Date:	22.05.25	Drawn: LK
Dwg No:	KL-602-002	Scale: 1:200 @ A0
Revision:	P1	
KOVA LANDSCAPE LTD www.kovalandscape.co.uk Tel: 01455 446866 Email: info@kovalandscape.co.uk		
The copyright of this drawing is vested in Kova Landscape Ltd. Reproduction in any form, either in whole or in part, is forbidden without the prior written permission of this copyright holder.		